


General Notes:

1. All ducting is indicative only, and needs to be coordinated with other existing and new underground services.
2. Connections subject to agreement with provider. Works to be completed by or on behalf of statutory undertaker.
3. Drawpit Chamber details to be agreed with the various providers.

Symbols Reference:

- 4no. 125mm ϕ Red ESB Ducts
- VIRGIN — Virgin Duct 125mm ϕ
- EIR — Eir Duct 125mm ϕ
- Draw Pit Chamber

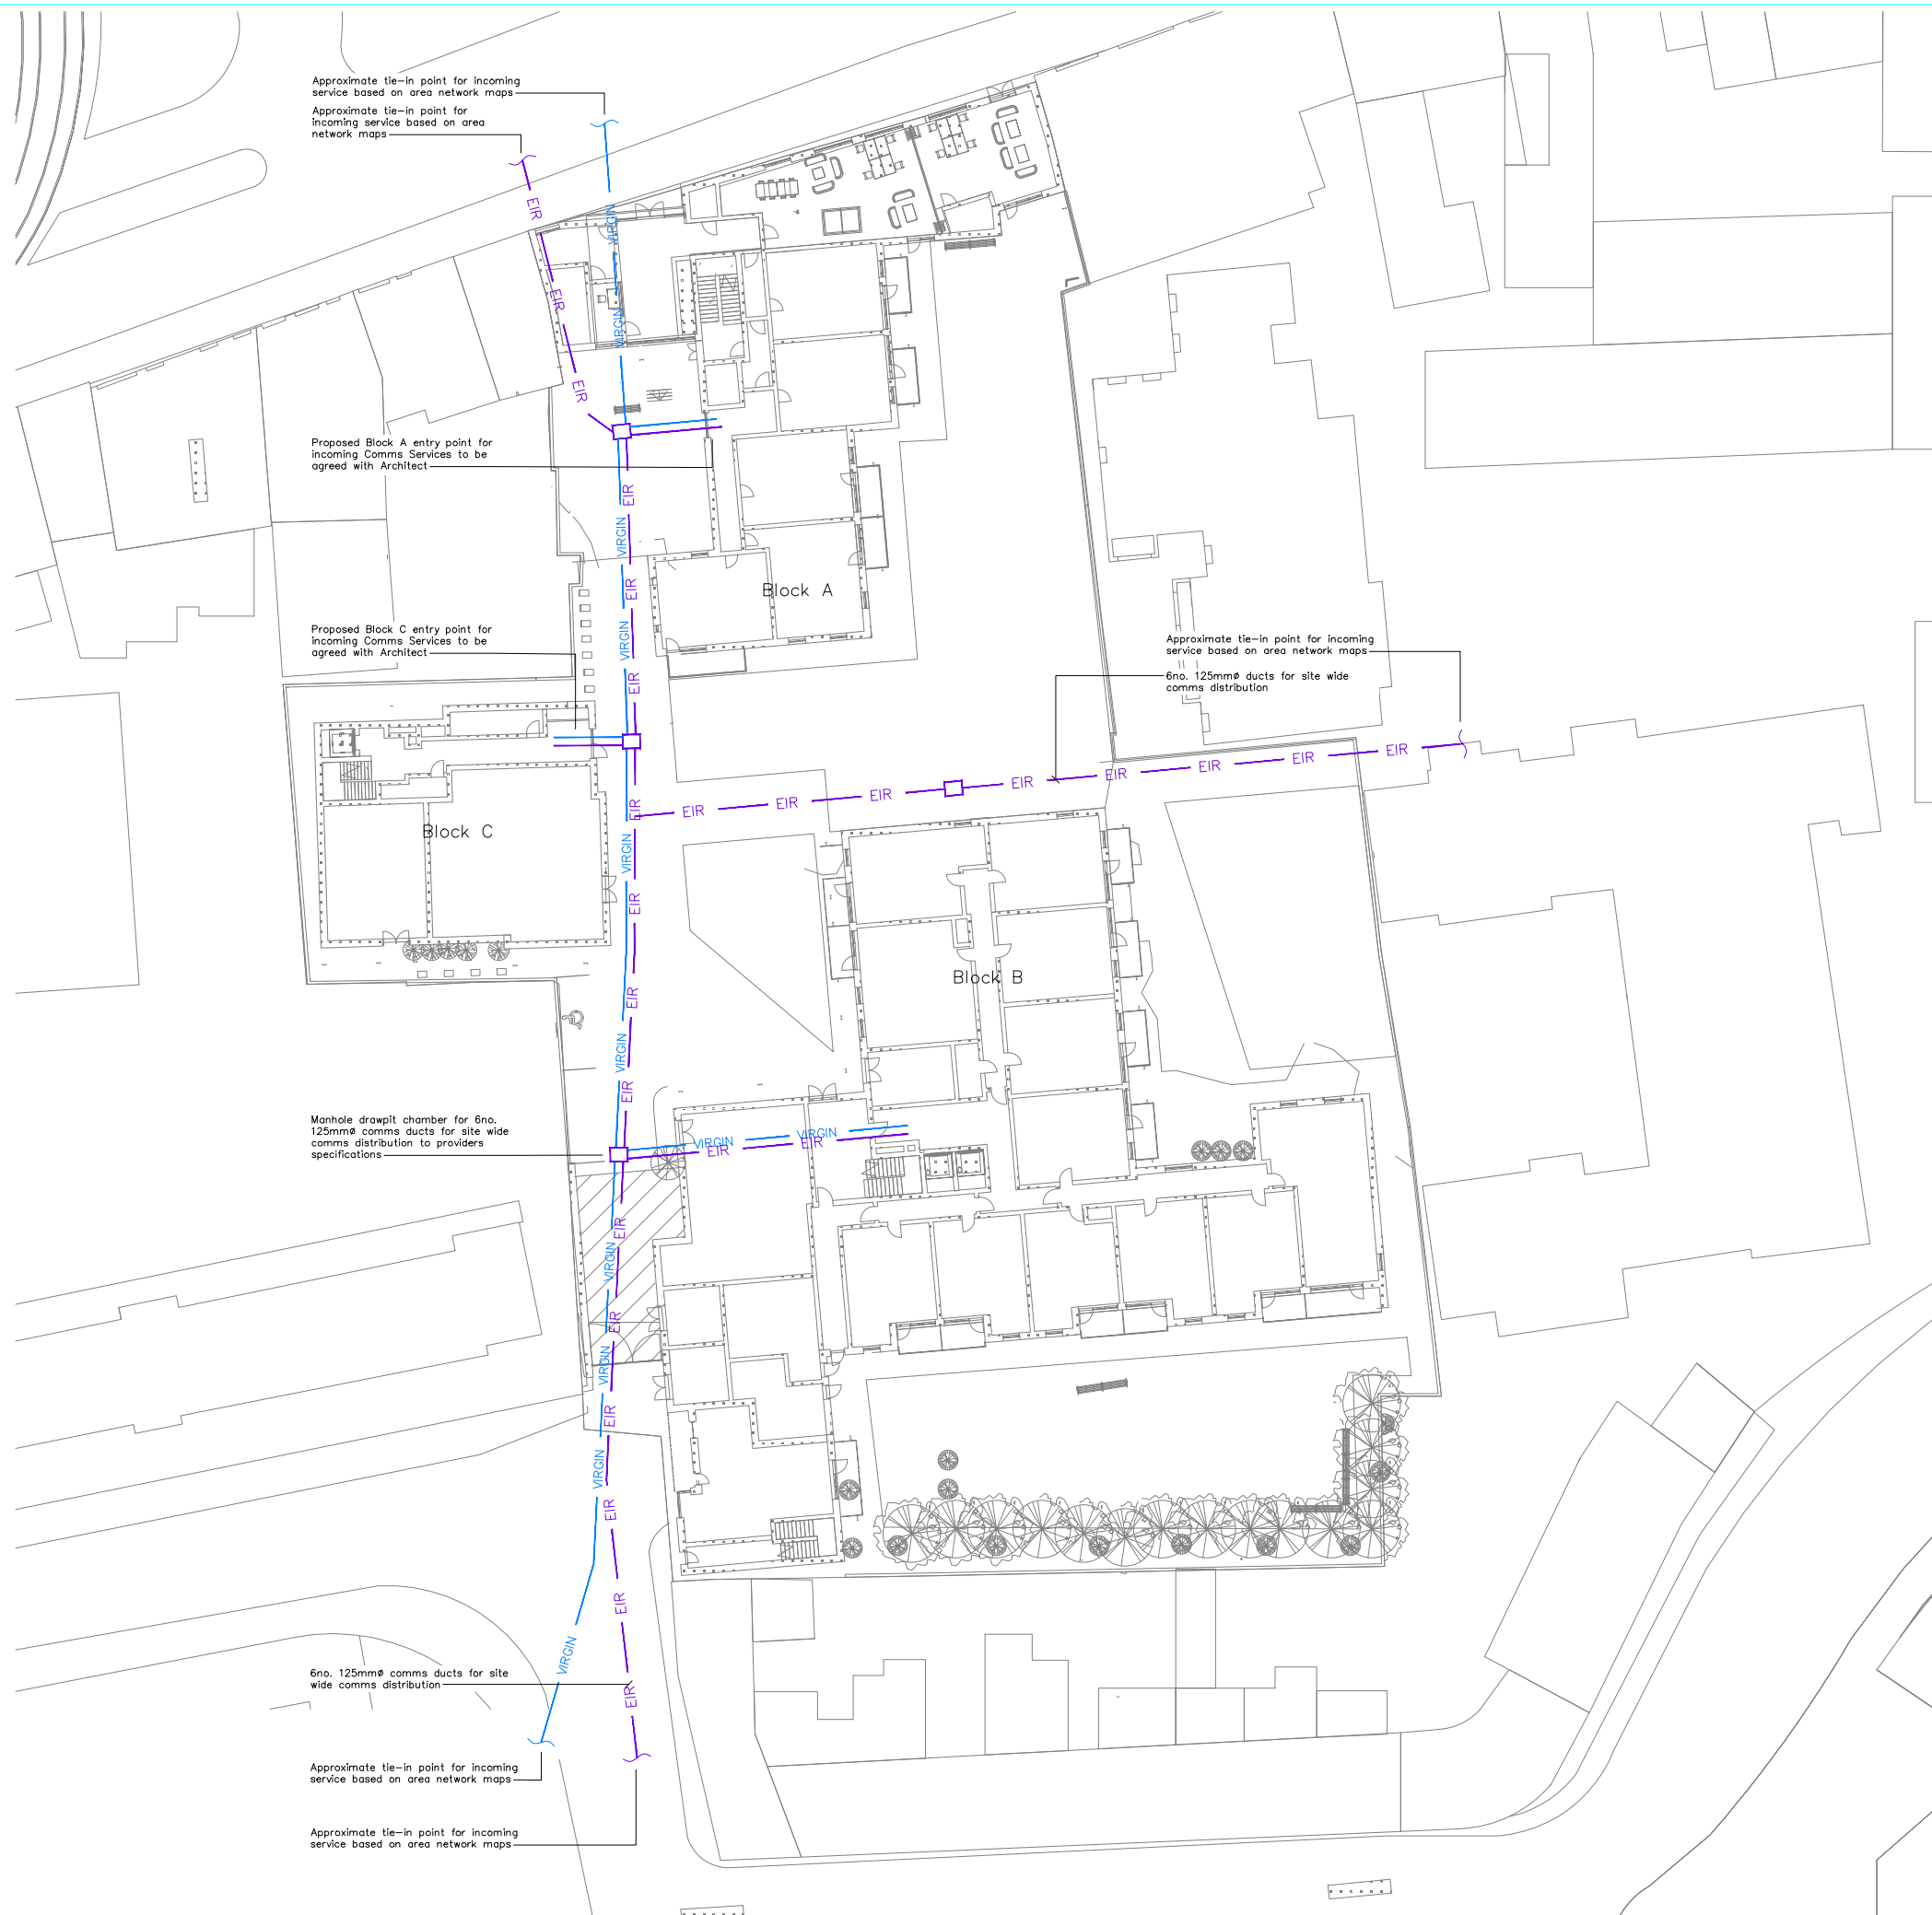

P01	19.11.20	Issued for Planning	HE	DP
REV	DATE	AMENDMENT	DRN	CHK

Issued for Information

		47 Mount Street Upper Dublin 2 Ireland D02 AC9S T: +353 1 491 0044 F: +353 1 491 3155 E: info@axiseng.ie www.axiseng.ie	
		Client: Cherry Core Limited & Jasmine Perfection Limited Architect: EML Architects	
Project: James' Street Apartments Site Plan Planning: Telecoms Site Ducting			
Drg. No: JSA-AXE-XX-XX-DR-E-60102			
Job No: 20009 Scale: 1:250 @ A1	Status: S2	Revision: P01	

This drawing is the property of axiseng. Copyright is reserved by axiseng and the drawing shall not be copied, reproduced or otherwise used without the consent of axiseng.ie.